


# CAMPO DE TIRO PARA RIFLE DE PEQUEÑO CALIBRE, PISTOLA Y CARABINA.

TORREJON AIR BASE

## RANGE, TARGET SMALL BORE RIFLE, PISTOL & CARBINE.

DENOMINACION DE PLANOS		DRAWING SCHEDULE	
HOJA Nº SHEET NO.	PLANO Nº DRAWING NO.	TITULO	TITLE
CE-1 OF 2	1663-3-1	PLANOS DE NIVELACION Y SITUACION.	GRADING & LOCATION PLANS.
CE-2 OF 2	1663-3-2	PLANO DE PAVIMENTACION, SERVICIOS Y SECCIONES DE NIVELACION.	PAVING & UTILITIES PLAN & GRADING SECTIONS.
AS-1 OF 2	1663-3-3	PLANTAS DE ARQUITECTURA, ESTRUCTURA, SECCIONES Y DETALLES.	ARCHITECTURAL & STRUCTURAL PLANS, SECTIONS & DETAILS.
AS-2 OF 2	1663-3-4	PLANTAS DE CIMENTACION, CUBIERTA Y DETALLES.	FOUNDATION & ROOFING PLANS & DETAILS.
ME-1 OF 1	1663-3-5	PLANTAS DE MECANICA, ELECTRICIDAD Y DETALLES.	MECHANICAL & ELECTRICAL PLANS & DETAILS.

CANTIDAD APROXIMADA DE MOVIMIENTO DE TIERRAS APPROXIMATE EARTHWORK QUANTITIES		
DESMONTE CUT	13,676 m <sup>3</sup>	TERRAPLEN FILL 13,507 m <sup>3</sup>

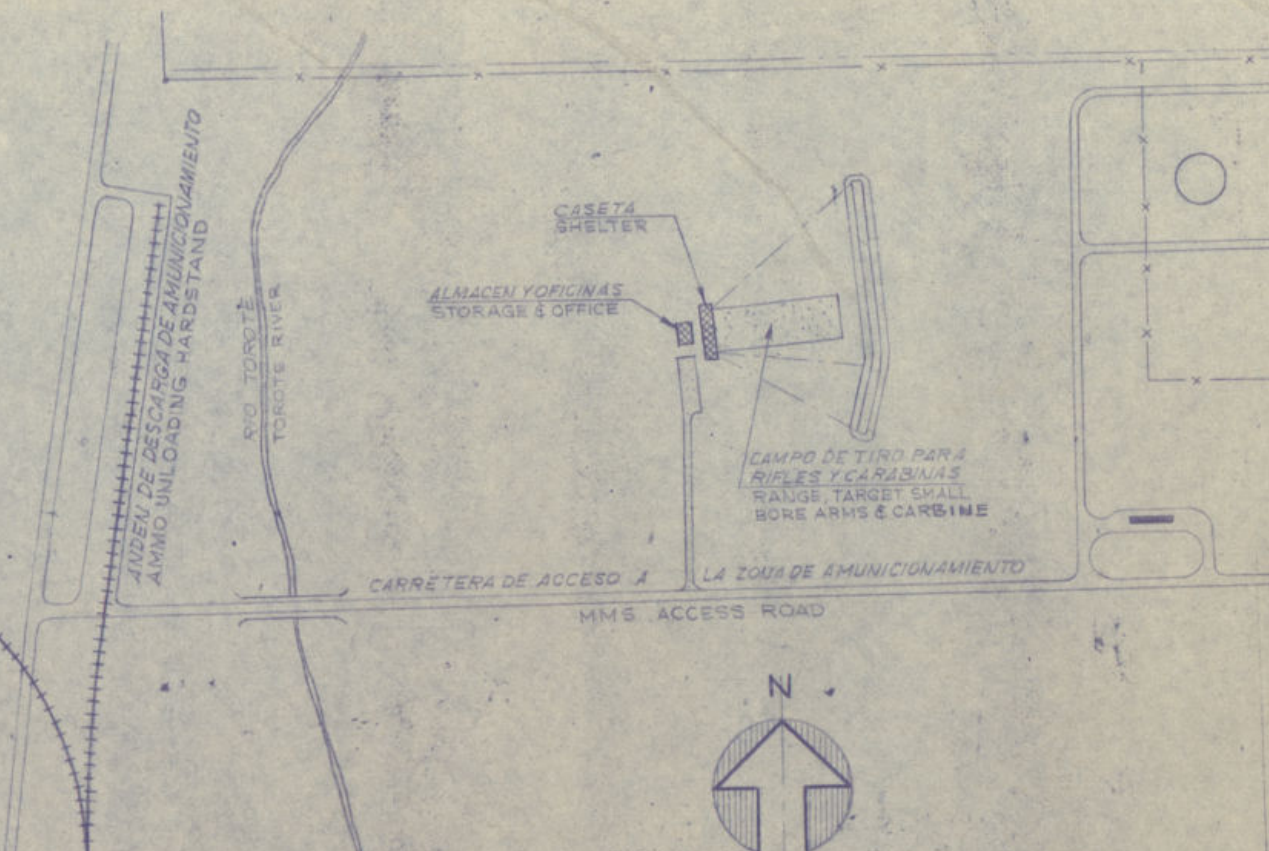

PLANO DE SITUACION  
LOCATION PLAN  
SCALE 1:5000

NOTES:

PARA SECCIONES VER HOJA CE-2 OF 2  
FOR SECTIONS SEE SHEET CE-2 OF 2  
PARA SECCIONES VER HOJA AS-1 OF 2  
FOR SECTIONS SEE SHEET AS-1 OF 2  
PARA SECCIONES VER HOJA ME-1 OF 1  
FOR SECTIONS SEE SHEET ME-1 OF 1

PROJECT NO. TOR 42-3		SCALE: AS SHOWN	
RECOMMENDED:	SUBMITTED: <i>Bohach</i>	DRAWN: <i>Sanchez</i>	DIRECTORATE OF SAFETY & LAW ENFORCEMENT
PROJECT OFFICER	ENGR. - IN CHARGE	DESIGNED BY: <i>Bohach</i>	
DRAWING NUMBER:	APPROVED:	CHECKED: <i>Bohach</i>	
1663-3-1		DATE: 11 DEC 62	DIRECTORATE OF SAFETY
SHEET CE 1 OF 2	CHIEF ENGINEERING DIV.		

745-415